


DRAINAGE DESIGN NOTES

1. ALL DRAINAGE SUBJECT TO MICRO-SITING AND OPTIMISATION ON SITE.
2. THE LOCATIONS OF THE INTERCEPTOR DRAINS, CHECK DAMS, CULVERTS, SWALES, STILLING PONDS AND LEVEL SPREADERS ARE SHOWN AS INDICATIVE, AND MAY BE CHANGED TO SUIT THE REQUIREMENTS OF THE LOCAL TOPOGRAPHY.
3. SUPERVISING HYDROLOGIST OR ENVIRONMENTAL CLERK OF WORKS (ENVIRONMENTAL SCIENTIST) TO OVERSEE INSTALLATION OF DRAINAGE FEATURES FOLLOWING DETAILED DRAINAGE DESIGN.
4. DRAINAGE MEASURES TO BE INSTALLED PRIOR TO, OR AT THE SAME TIME AS THE WORKS AREAS THEY ARE INTENDED TO DRAIN.
5. DESIGN ELEVATION OF THE WATER SURFACE ALONG THE ROUTE OF THE INTERCEPTOR DRAINS OR SWALES WILL NOT BE LOWER THAN THE DESIGN ELEVATION OF THE WATER SURFACE IN THE OUTLET AT THE LEVEL SPREADER OR STILLING POND.
6. THE SPACING AND FREQUENCY OF THE CHECK DAMS WILL BE DEPENDANT ON THE GRADIENT OF THE INTERCEPTOR DRAIN OR SWALE IN WHICH THEY ARE BEING INSTALLED.
7. CHECK DAM DESIGNS TO BE SELECTED BEST TO SUIT PARTICULAR TOPOGRAPHY AND HYDROLOGICAL ENVIRONMENT.
8. DOWN GRADIENT SLOPE BELOW LEVEL SPREADER ONTO WHICH THE WATER WILL DISSIPATE TO HAVE A GRADE LESS THAN THE 6%.
9. NO DIRECT DISCHARGE OR PUMPING TO WATERCOURSES WILL BE PERMITTED. ALL DISCHARGES FROM LEVEL SPREADERS OR STILLING PONDS TO BE VIA VEGETATED FILTERS. SELECTION OF SUITABLE AREAS TO USE AS VEGETATION FILTERS WILL BE DETERMINED BY THE SIZE OF THE CONTRIBUTING CATCHMENT, SLOPE AND GROUND CONDITIONS.
10. STILLING PONDS TO BE SIZED ACCORDING TO THE AREA THEY WILL BE RECEIVING WATER FROM.
11. DIVERSION OF DRAINAGE DITCHES WILL ONLY TAKE PLACE WHEN ALTERNATIVE DRAINAGE DITCH HAS BEEN INSTALLED TO HANDLE THE SAME WATER.
12. EXISTING DRAINS/DITCHES TO BE INCORPORATED OR REMOVED DURING WIND FARM CONSTRUCTION.
13. ALL DRAINAGE SYSTEM FEATURES TO BE SUBJECT OF INSPECTION AND MAINTENANCE PLAN.
14. THE LAYOUT SHOWN IS SLIGHTLY OFFSET FOR SCALE PURPOSES, AND ALL DRAINAGE WOULD BE INSTALLED AS CLOSE TO THE ROAD AS POSSIBLE.
15. DRAINAGE ASSIGNED TO FLOATING ROAD SECTIONS OF THE LAYOUT WILL BE SUBJECT TO FURTHER OPTIMISATION IN PARALLEL WITH DETAILED GEOTECHNICAL DESIGN.

MITIGATION / DRAINAGE CONTROLS AVAILABLE FOR USE ACROSS THE SITE

Management Type	Description of SUDS Drainage Control Methods
AVOIDANCE CONTROLS	<ul style="list-style-type: none"> 1) APPLICATION OF 50M BUFFER ZONES TO NATURAL WATERCOURSES WHERE POSSIBLE 2) APPLICATION OF 50M BUFFER ZONES TO ARTIFICIAL DRAINAGE DITCHES WHERE POSSIBLE 3) USING SMALL WORKING AREAS 4) WORKING IN APPROPRIATE WEATHER AND SUSPENDING CERTAIN WORK ACTIVITIES IN ADVANCE OF FORECASTED WET WEATHER.
SOURCE CONTROLS	<ul style="list-style-type: none"> 1) USE OF UPSTREAM INTERCEPTOR DRAINS AND DOWNSTREAM COLLECTOR DRAINS / OVERSIZED SWALES, VEGETATED DIVERSION DRAINS, FILTERS AND SILENT PIPES 2) EROSION AND VELOCITY CONTROL MEASURES SUCH AS: <ul style="list-style-type: none"> a) SAND BAGS b) OYSTER BAGS FILLED WITH GRAVEL c) FILTER FABRICS d) LOGS AND OTHER SIMILAR/EQUIVALENT OR APPROPRIATE SYSTEMS 3) USING SMALL WORKING AREAS 4) COVERING STOCKPILES 5) WEATHERING OFF / SEALING PEAT STOCKPILES
IN-LINE CONTROLS	<ul style="list-style-type: none"> 1) INTERCEPTOR DRAINS, VEGETATED SWALES/COLLECTOR DRAINS 2) EROSION AND VELOCITY CONTROL MEASURES SUCH AS: <ul style="list-style-type: none"> a) SAND BAGS b) OYSTER BAGS FILLED WITH GRAVEL c) FILTER FABRICS d) STRAW BALES e) FLOW LITTERS f) WEIRS OR Baffles g) LOGS OR OTHER SIMILAR/EQUIVALENT OR APPROPRIATE SYSTEMS 3) SILT FENCES, FILTER FABRICS 4) IN STREAM SEDIMENTS 5) COLLECTION PIPES, TEMPORARY SUMP, PUMPING SYSTEMS 6) ATTENUATION LAGOONS 7) SEDIMENT TRAPS, STILLING / SETTLEMENT PONDS
WATER TREATMENT CONTROLS	<ul style="list-style-type: none"> 1) TEMPORARY SUMPS 2) ATTENUATION PONDS 3) TEMPORARY STORAGE LAGOONS 4) SEDIMENT TRAPS, STILLING / SETTLEMENT PONDS 5) PROPRIETARY SETTLEMENT SYSTEMS SUCH AS SILTTRAP, AND/OR OTHER EQUIVALENTS OF APPROPRIATE SYSTEMS 6) SALT DEWATERING BAGS
OUTFALL CONTROLS	<ul style="list-style-type: none"> 1) LEVEL SPREADERS 2) BUFFERED OUTFALLS 3) VEGETATION FILTERS 4) SALT DEWATERING BAGS 5) FLOW LITTERS AND WEIRS

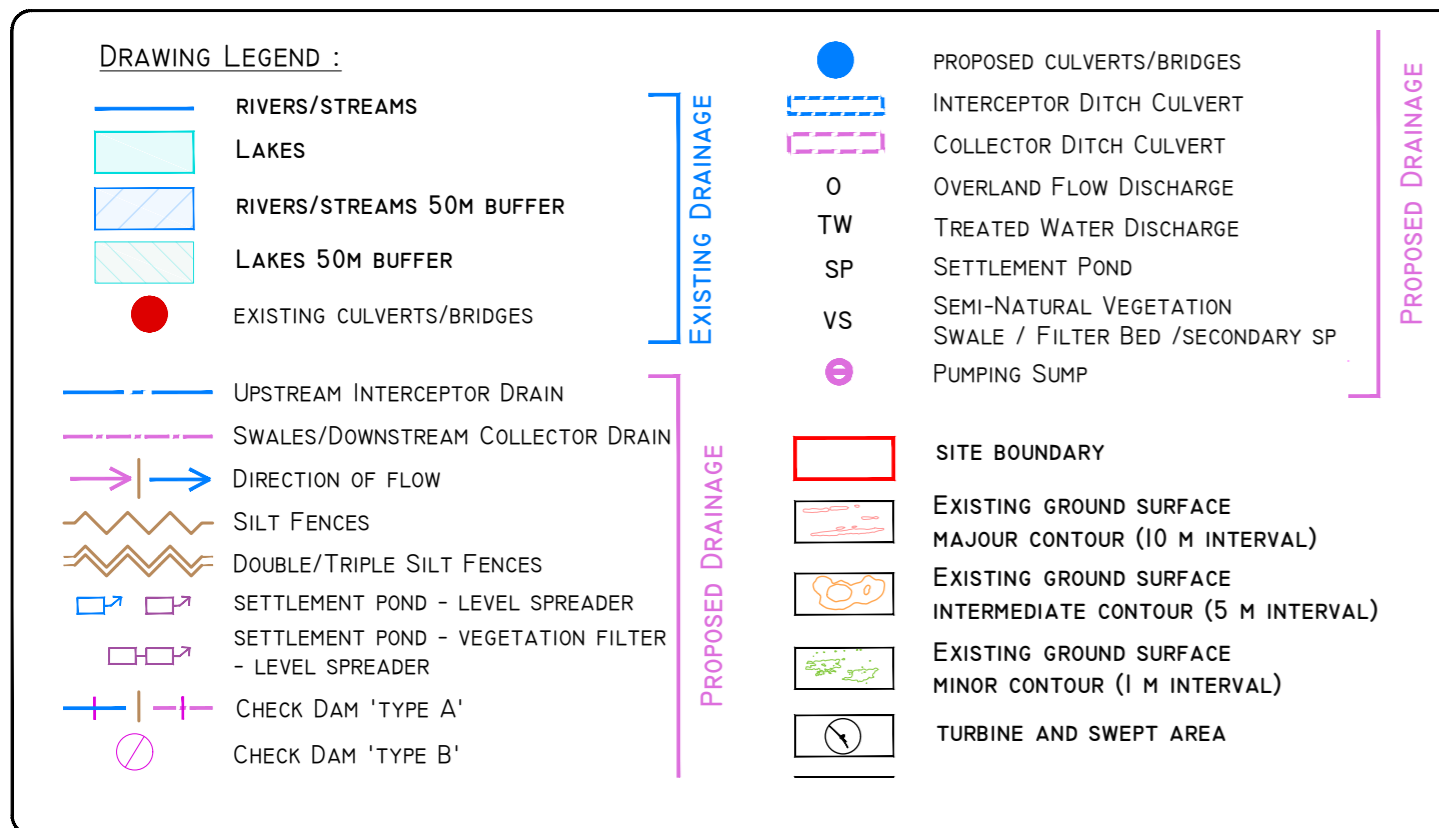

PROJECT DESIGN DRAWING NOTES

1. DRAWINGS ISSUED ARE FOR PLANNING APPLICATION PURPOSES ONLY.
2. DRAWINGS NOT TO BE USED FOR CONSTRUCTION / CONTRACT CONDITIONS.
3. COPYRIGHT, ALL RIGHTS RESERVED. NO PART HERE WITH MAY BE COPIED OR REPRODUCED PARTIALLY OR WHOLLY IN ANY FORM WHATSOEVER WITHOUT THE PRIOR NOTICE OF THE COPYRIGHT OWNER HYDRO-ENVIRONMENTAL SERVICES.
4. DO NOT SCALE OFF THIS DRAWING. FIGURED METRIC DIMENSIONS ONLY SHOULD BE TAKEN OFF THIS DRAWING.
5. ALL CONTRACTORS, WEATHER MAIN OR SUB-CONTRACTORS, MUST VISIT THE SITE AND ARE RESPONSIBLE FOR TAKING AND CHECKING ANY AND ALL DIMENSIONS AND LEVELS THAT RELATE TO THE WORKS.
6. THE USE OF OR RELIANCE UPON THIS DRAWING SHALL BE DEEMED TO BE ACCEPTANCE OF THESE CONDITIONS OF USE UNLESS OTHERWISE AGREED IN WRITING. SUCH WRITTEN AGREEMENT TO BE SOUGHT FROM AND ISSUED BY THE COPYRIGHT HOLDER TO THE USE OR RELIANCE UPON THIS DRAWING.
7. LAYOUT PLANS SHOW TYPICAL TURBINE ROTOR DIAMETER AS PER TURBINE DRAWING.

Ordnance Survey Ireland Licence No. EN 0044718
© Ordnance Survey Ireland/Government of Ireland

Date Description Chkd Signed

Revisions

HYDRO ENVIRONMENTAL SERVICES
22 Lower Main St
Dungarvan
Co. Waterford
Ireland

tel: +353 (0) 58-44122
tel: +353 (0) 58-44244
email: info@hydroenvironmental.ie
web: www.hydroenvironmental.ie

Client:	MCCARTHY KEVILLE O'SULLIVAN
Job:	ARDDERROO WF, CO. GALWAY
Title:	Drainage Layout Sheet 4 of 10
Figure No:	0815-23
Drawing No:	P1227-8-1118-A1-0815-23-00A
Sheet Size:	A1
Scale:	1:2,000 (A1)
Date:	21/11/2018
Project No.:	P1227-8
Drawn By:	GD
Checked By:	MG